


KEY PLAN - N.T.S.

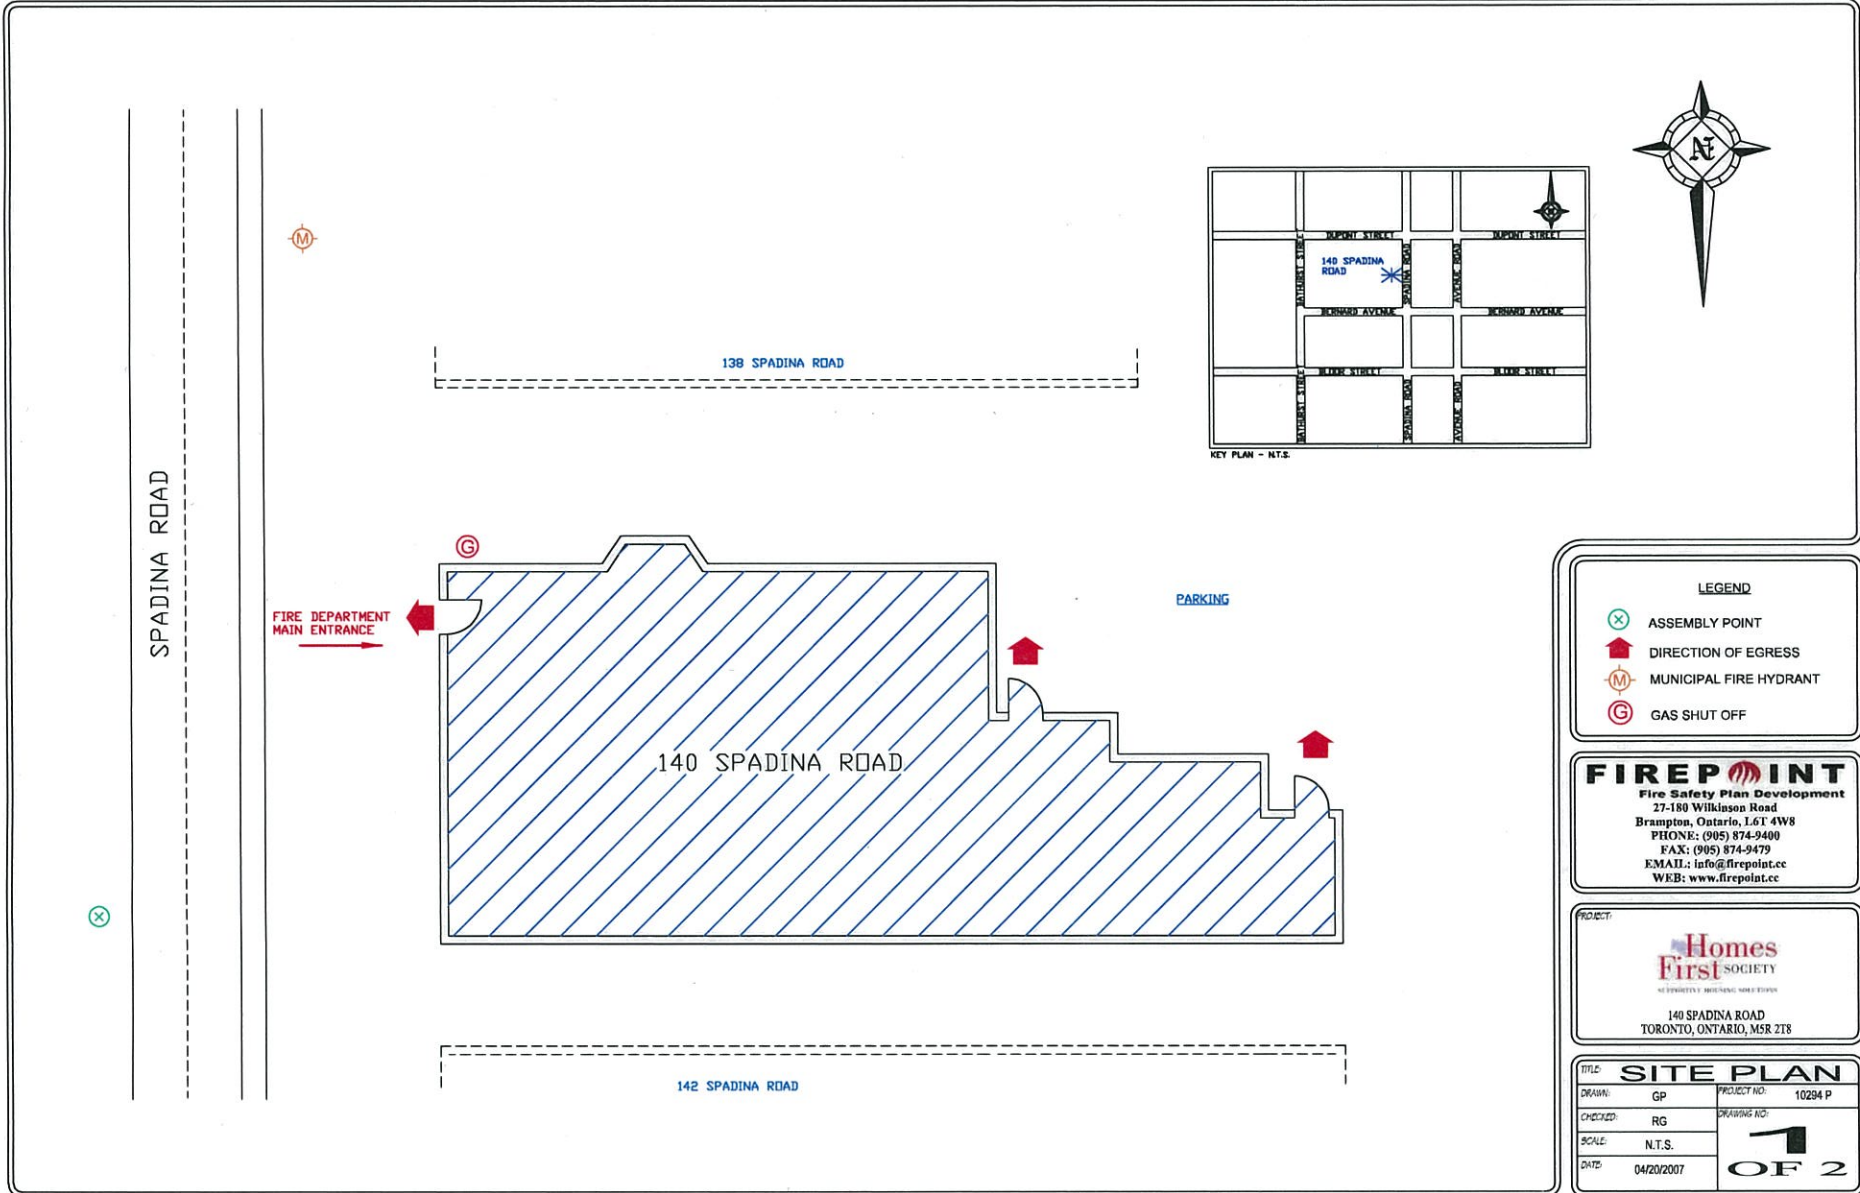

LEGEND

- ASSEMBLY POINT
- DIRECTION OF EGRESS
- MUNICIPAL FIRE HYDRANT
- GAS SHUT OFF

FIREPOINT
 Fire Safety Plan Development
 27-180 Wilkison Road
 Brampton, Ontario, L6T 4W8
 PHONE: (905) 874-9400
 FAX: (905) 874-9479
 EMAIL: info@firepoint.ca
 WEB: www.firepoint.ca

PROJECT:

 140 SPADINA ROAD
 TORONTO, ONTARIO, M5R 2T8

TITLE: SITE PLAN	
DRAWN: GP	PROJECT NO: 10294 P
CHECKED: RG	DRAWING NO: 1
SCALE: N.T.S.	 OF 2
DATE: 04/20/2007	