

## IN CASE OF FIRE

### UPON DISCOVERY OF FIRE

LEAVE FIRE AREA IMMEDIATELY.  
CLOSE DOORS.  
SOUND THE FIRE ALARM.  
PULL THE MANUAL STATION.  
LEAVE THE BUILDING BY THE NEAREST EXIT.

CALL THE FIRE DEPARTMENT  
DIAL **911**

### DO NOT USE ELEVATORS

### UPON HEARING FIRE ALARM

LEAVE THE BUILDING BY THE NEAREST EXIT.  
CLOSE DOORS BEHIND YOU.

### CAUTION

IF SMOKE IS HEAVY IN THE CORRIDOR, IT  
MAY BE SAFER TO STAY IN YOUR AREA.  
CLOSE DOOR AND PLACE WET TOWEL AT  
BASE OF DOOR.

IF YOU ENCOUNTER SMOKE IN THE  
STAIRWAY, USE AN ALTERNATE EXIT.

## REMAIN CALM

### FALSE ALARM

\* Everyone who willfully, without reasonable cause, in any  
MANNER, makes or causes to be made an alarm of FIRE  
is Guilty of an offence." Criminal Code (Canada)

PROJECT:




## FIREPOINT

Fire Safety Plan Development

27 - 180 Wilkinson Road, Brampton ON L6T 4W8  
PHONE: (905) 874-9400 FAX: (905) 874-9479  
EMAIL: info@firepoint.ca WEB: www.firepoint.ca

COPYRIGHT © FIREPOINT INC.

Permission to be granted to create derivative schematics  
or reproductions of this document's contents

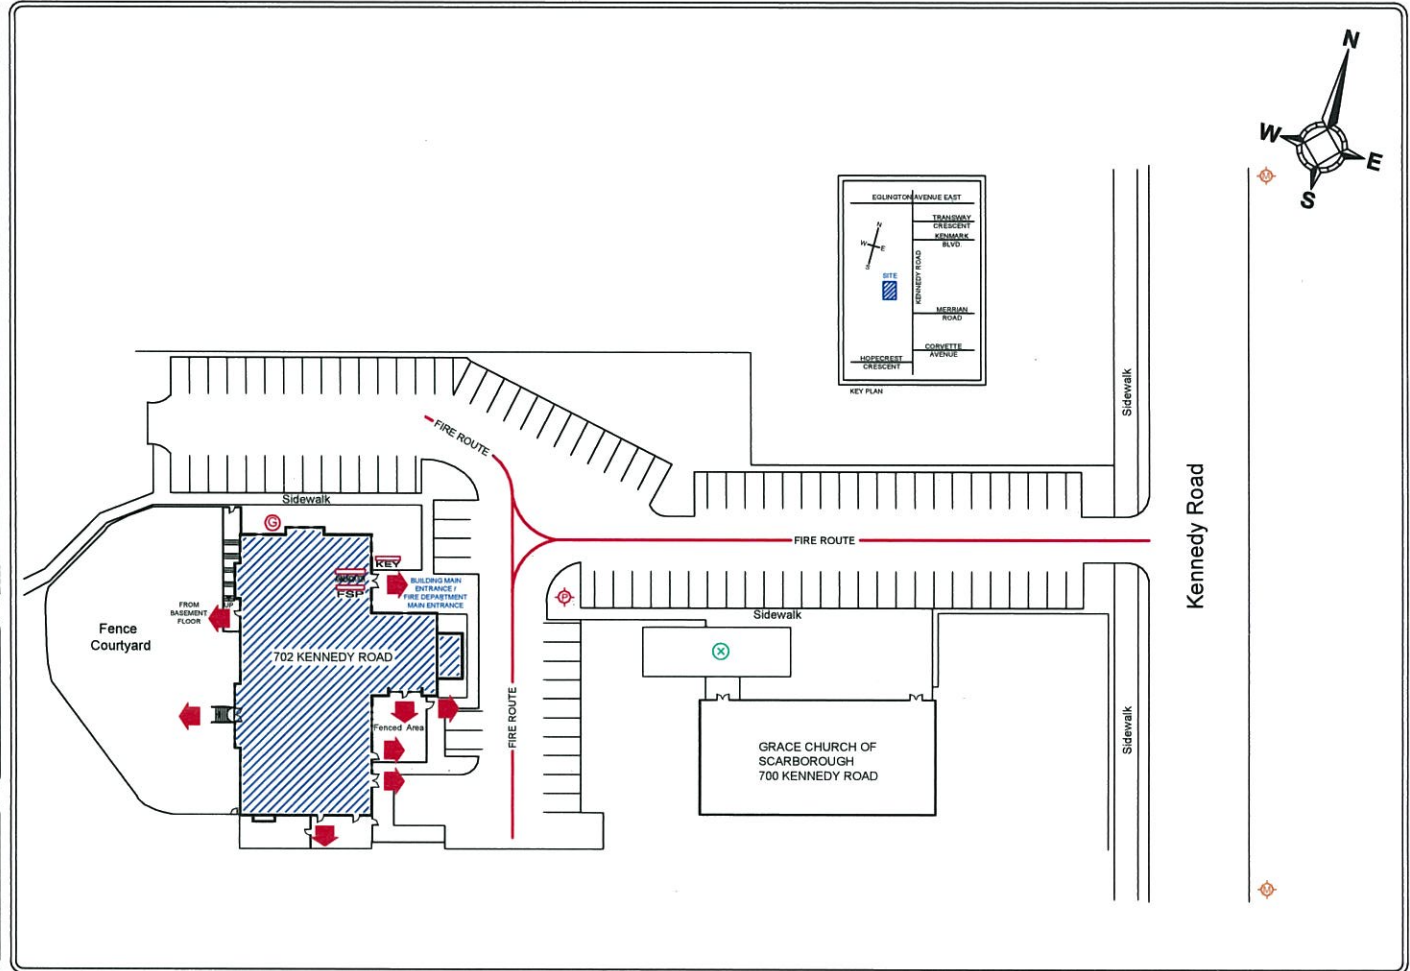

### LEGEND

	EMERGENCY KEY BOX		MUNICIPAL FIRE HYDRANT
	FIRE SAFETY PLAN BOX		DESIGNATED ASSEMBLY AREA
	DIRECTION OF EGRESS		FIRE ALARM ANNUNCIATOR PANEL
	GAS SHUT OFF		PRIVATE FIRE HYDRANT

TITLE		<b>SITE PLAN</b>	
DRAWN: PC	SCALE: NOT TO SCALE	PROJECT NO: 13921	
PROJECT DATE: FEBRUARY 6, 2018		DWG. REVISION: SCHEMATIC RE-DRAWN	
REVISION DATE:		DRAWING NO: 1	
APPROVED DATE: JULY 6, 2018			OF 4