

IN CASE OF FIRE

UPON DISCOVERY OF FIRE

LEAVE FIRE AREA IMMEDIATELY.
CLOSE DOORS.
SOUND THE FIRE ALARM.
PULL THE MANUAL STATION.
LEAVE THE BUILDING BY THE NEAREST EXIT.

CALL THE FIRE DEPARTMENT
DIAL **911**

UPON HEARING FIRE ALARM

LEAVE THE BUILDING BY THE NEAREST EXIT.
CLOSE DOORS BEHIND YOU.

CAUTION

IF SMOKE IS HEAVY IN THE CORRIDOR, IT
MAY BE SAFER TO STAY IN YOUR AREA.
CLOSE DOOR AND PLACE WET TOWEL AT
BASE OF DOOR.

IF YOU ENCOUNTER SMOKE IN THE
STAIRWAY, USE AN ALTERNATE EXIT.

REMAIN CALM

FALSE ALARM

*Everyone who willfully, without reasonable cause, in any
MANNER, makes or causes to be made an alarm of FIRE
is guilty of an offence.* Criminal Code (Canada)

PROJECT:



Everyone needs a home

175 VAUGHAN ROAD
YORK, ONTARIO, M6C 2M4


FIREPOINT

Fire Safety Plan Development


27 - 180 Wilkinson Road, Brampton ON L6T 4W8
PHONE: (905) 874-9400 FAX: (905) 874-9479
EMAIL: info@firepoint.ca WEB: www.firepoint.ca

COPYRIGHT © FIREPOINT INC.

Permission to be granted to create derivative schematics
or reproductions of this documents' contents

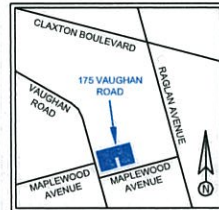

KEY PLAN

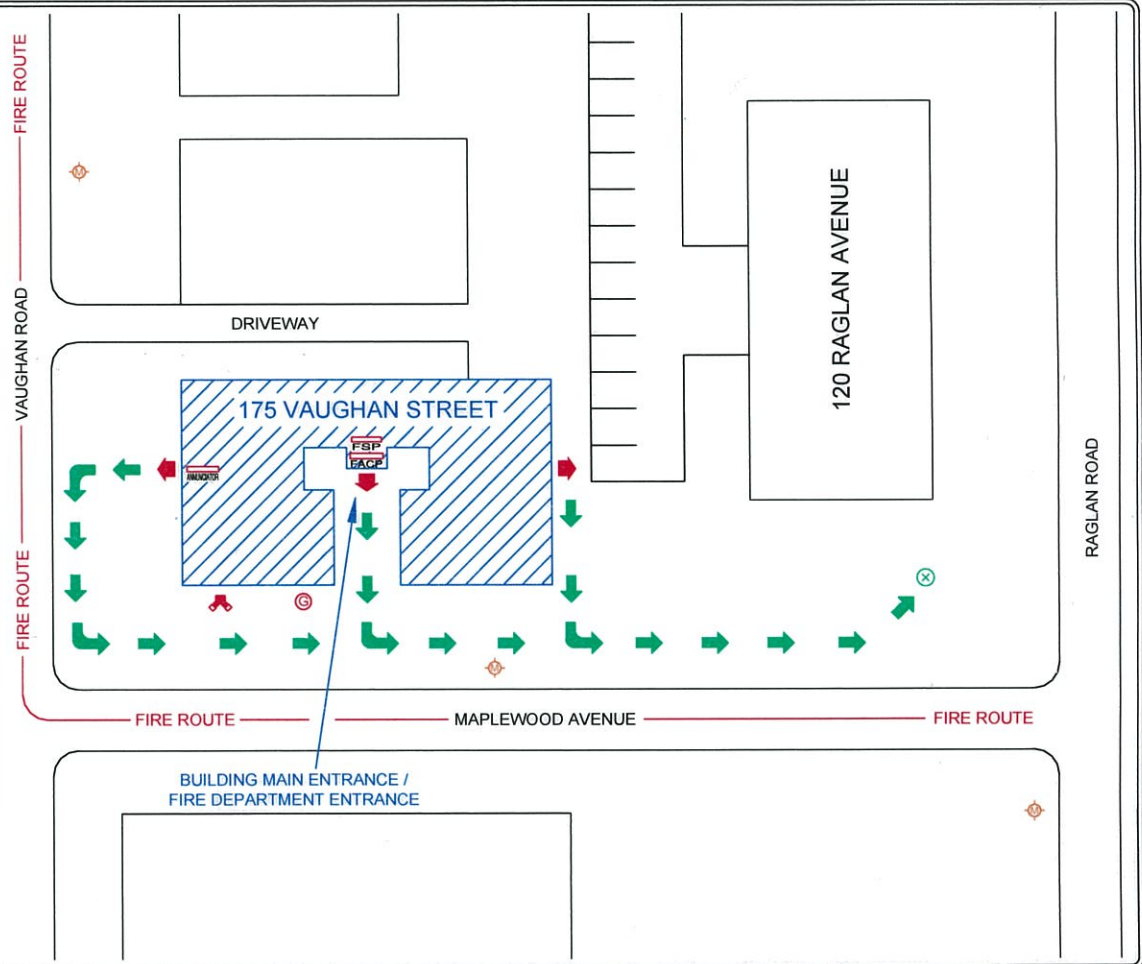

LEGEND

- | | | |
|------------------------------|------------------------|----------------------------------|
| FIRE SAFETY PLAN BOX | DIRECTION OF EGRESS | PATH TO DESIGNATED ASSEMBLY AREA |
| FIRE ALARM CONTROL PANEL | GAS SHUT OFF | DESIGNATED ASSEMBLY AREA |
| FIRE ALARM ANNUNCIATOR PANEL | MUNICIPAL FIRE HYDRANT | FIRE DEPARTMENT CONNECTION |

TITLE: SITE PLAN

DRAWN: JR	SCALE: NOT TO SCALE	PROJECT NO: 14062
PROJECT DATE: NOVEMBER 6, 2018	DWG REWORK PERMISSION: SCHEMATIC RE-DRAWN	
REVISION DATE:	DRAWING NO:	
APPROVED DATE: JANUARY 9, 2019	OF 6	