

IN CASE OF FIRE

UPON DISCOVERY OF FIRE

LEAVE FIRE AREA IMMEDIATELY.
CLOSE DOORS.
SOUND THE FIRE ALARM.
PULL THE MANUAL STATION.
LEAVE THE BUILDING BY THE NEAREST EXIT.

CALL THE FIRE DEPARTMENT
DIAL **911**

UPON HEARING FIRE ALARM

LEAVE THE BUILDING BY THE NEAREST EXIT.
CLOSE DOORS BEHIND YOU.

CAUTION

IF SMOKE IS HEAVY IN THE CORRIDOR, IT
MAY BE SAFER TO STAY IN YOUR AREA.
CLOSE DOOR AND PLACE WET TOWEL AT
BASE OF DOOR.

IF YOU ENCOUNTER SMOKE IN THE
STAIRWAY, USE AN ALTERNATE EXIT.

REMAIN CALM

FALSE ALARM

* Everyone who willfully, without reasonable cause, in any
MANNER, makes or causes to be made an alarm of FIRE
is guilty of an offence. Criminal Code (Canada)

PROJECT:



Everyone needs a home

175 VAUGHAN ROAD
YORK, ONTARIO, M6C 2M


FIREPOINT

Fire Safety Plan Development

27 - 180 Wilkinson Road, Brampton ON L6T 4W8
PHONE: (905) 874-9400 FAX: (905) 874-9479
EMAIL: info@firepoint.ca WEB: www.firepoint.ca

COPYRIGHT © FIREPOINT INC.

Permission to be granted to create derivative schematics
or reproductions of this documents' contents

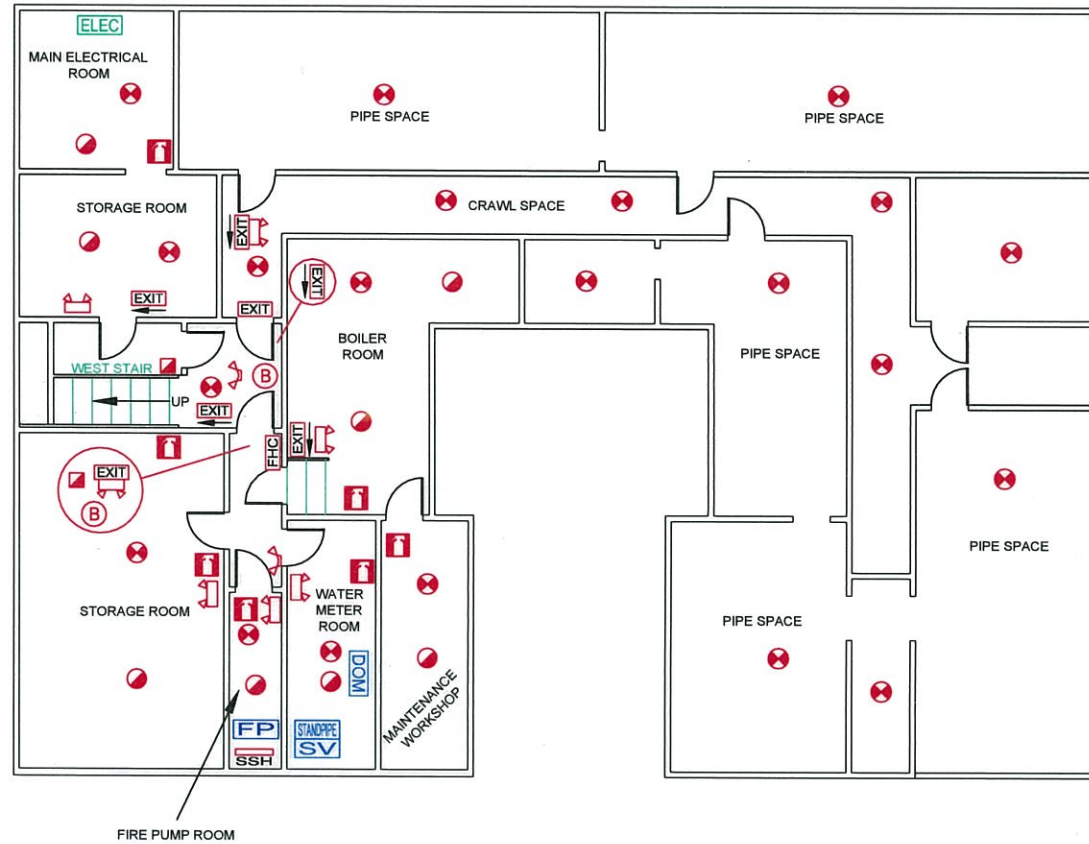

LEGEND

	FIRE EXTINGUISHER		DOMESTIC WATER SHUTOFF		FIRE ALARM BELL		FIRE HOSE CABINET WITH FIRE EXTINGUISHER
	EXIT SIGN		SPRINKLER SHUTOFF VALVE		SMOKE DETECTOR		MANUAL PULL STATION
	EMERGENCY LIGHT WITH BATTERY PACK		FIRE PUMP		HEAT DETECTOR		MAIN ELECTRICAL DISCONNECT
	EMERGENCY LIGHT REMOTE UNIT		STANDPIPE SHUTOFF VALVE		SPARE SPRINKLER HEAD BOX		

TITLE: BASEMENT FLOOR PLAN		
DRAWN: JR	SCALE: NOT TO SCALE	PROJECT NO: 14082
PROJECT DATE: NOVEMBER 6, 2018		DWG REVIEW PERMISSION: SCHEMATIC RE-DRAWN
REVISION DATE:		DRAWING NO:
APPROVED DATE: JANUARY 9, 2019		
		OF 6