






Drawing Legend

-  Siamese Connection
-  Main Gas Shutoff Valve
-  Municipal Fire Hydrant
-  Designated Assembly Area
-  Emergency Exit

Project Title

800-ADELAIDE-ST-WEST.

Drawing Title

SITE-PLAN

Consultant's Seal

Consultant:

Designed:

Drawn:
SEAN WANG

Reviewed:

Approved:

Architect's Seal

Date:
OCTOBER-28-2016

Project No.:
PROJECT-NO.4


Scale:
NTS

Drawing No.:

1-OF-9

Unless otherwise specified, all measurements are inches

D

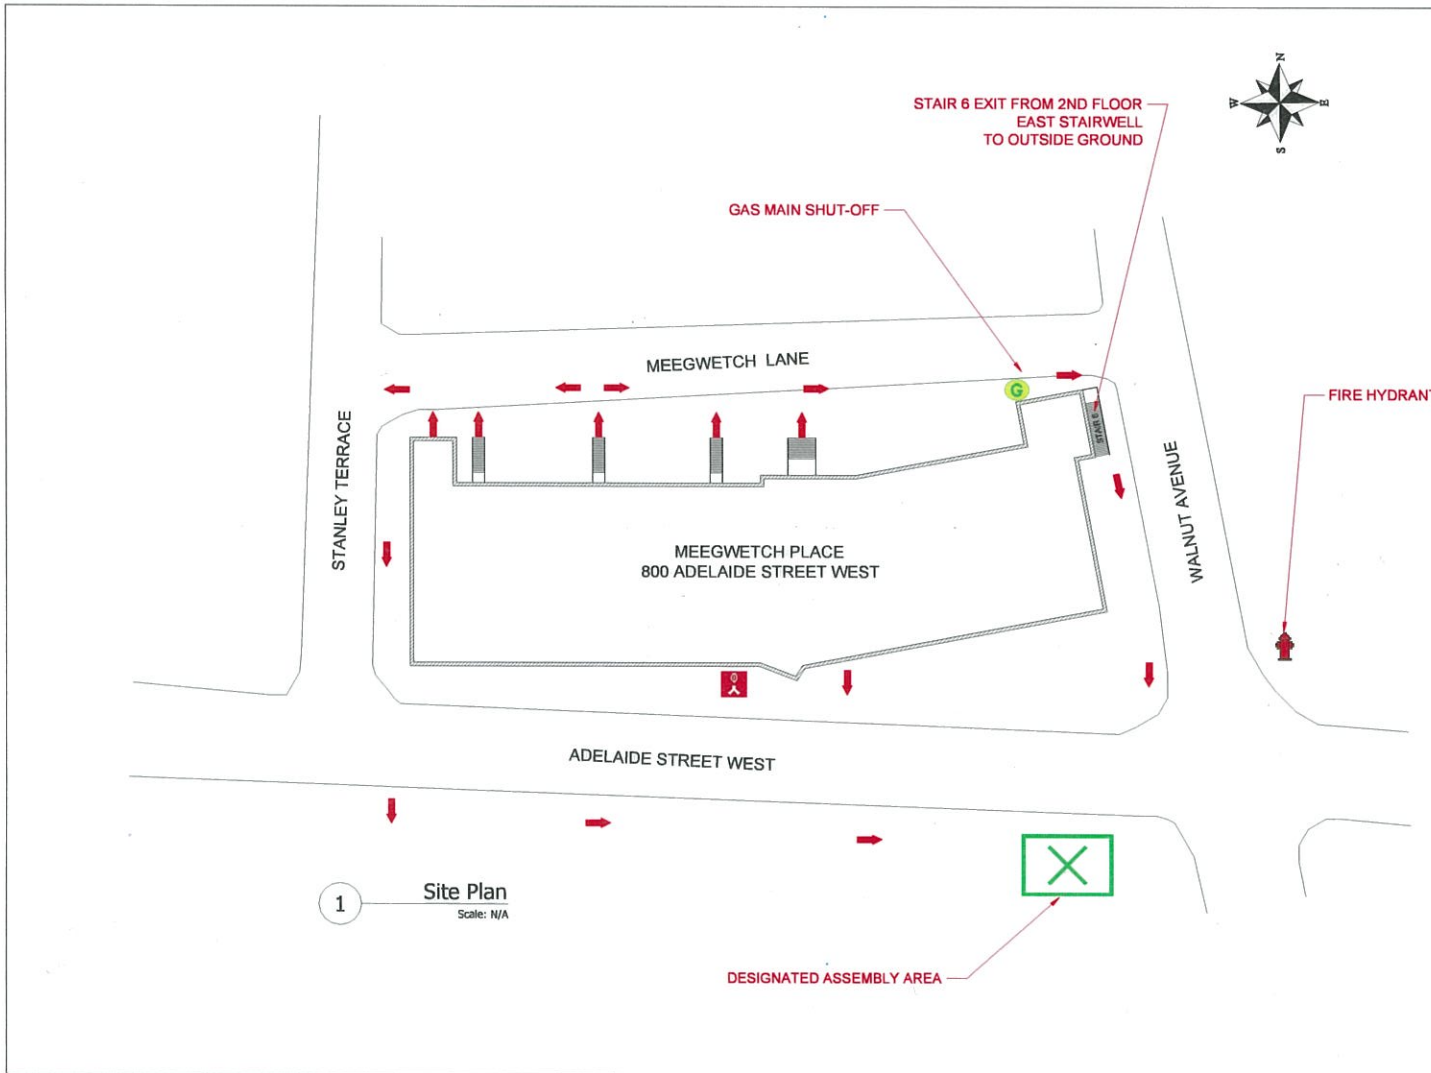

1 Site Plan
Scale: N/A