

Drawing Legend


- EXIT Exit Sign
- Horn
- Manual Pull Station
- Fire Extinguisher
- EL Emergency Lighting
- Smoke Detector
- Heat Detector
- Carbon Monoxide Detector
- FHC Fire Hose Cabinet
- Emergency Exit

Project Title
800-ADELAIDE-ST-WEST

Drawing Title
2ND-FLOOR-PLAN

Consultant's Seal	Consultant:
	Designed:
	Drawn: SEAN WANG
	Reviewed:
Approved:	
Architect's Seal	Date: OCTOBER-28-2016
	Project No.: PROJECT-NO.4
	Scale: NTS
	Drawing No.: 6-OF-9

Unless otherwise specified, all measurements are inches

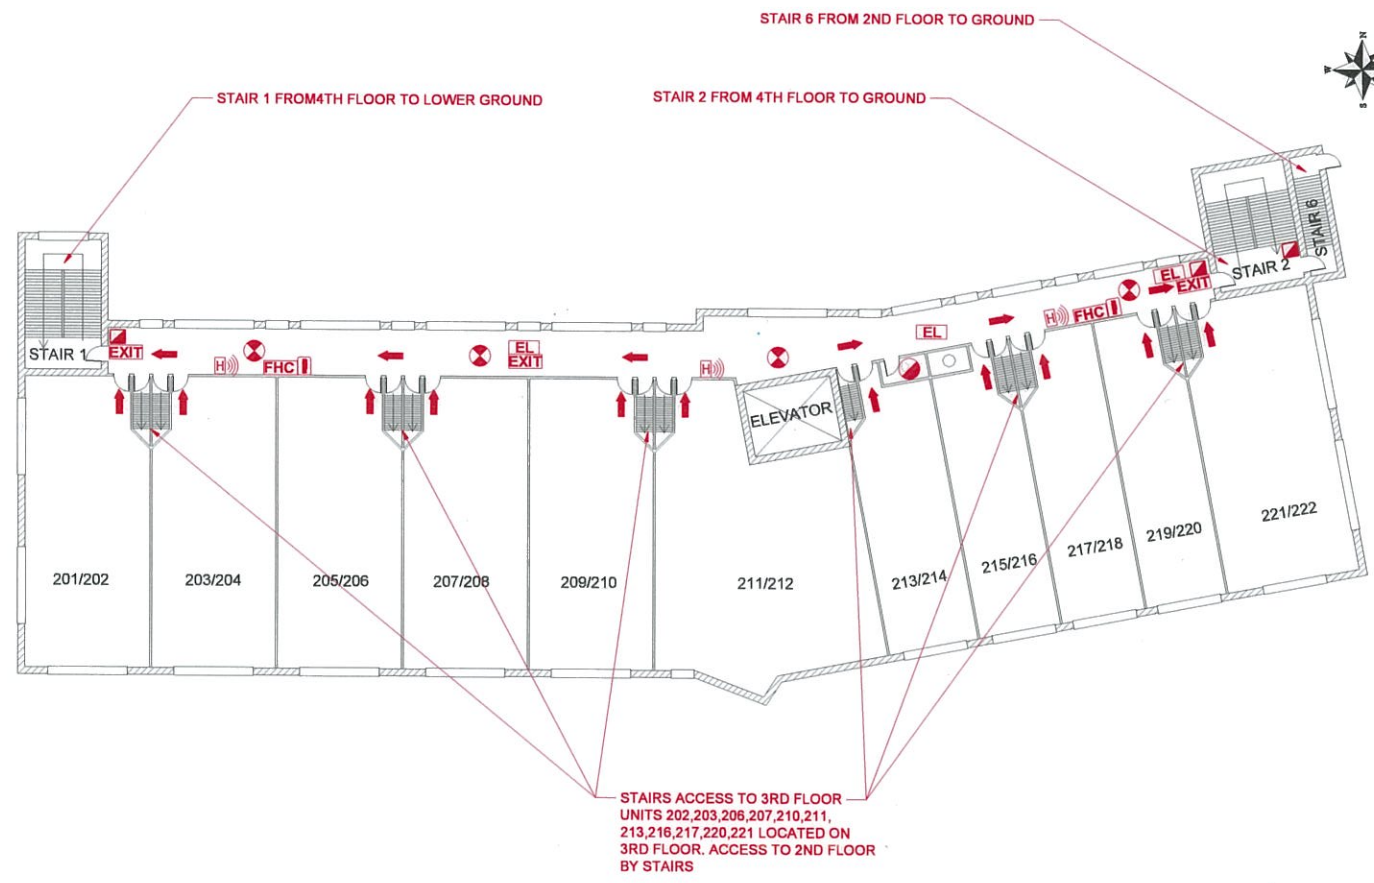

STAIRS ACCESS TO 3RD FLOOR
 UNITS 202,203,206,207,210,211,
 213,216,217,220,221 LOCATED ON
 3RD FLOOR. ACCESS TO 2ND FLOOR
 BY STAIRS

6 2nd Floor Plan
 Scale: N/A

D