

1-OF-1

Unless otherwise specified, all measurements are in inches

Drawing No.: **NTS**
 Scale: **NTS**
 Project No.: **PROJECT-NO.4**
 Date: **OCTOBER-31-2018**

Architect's Seal

Approved: _____
 Reviewed: **SEAN WANG**
 Drawn: _____
 Consultant:

Project Title: **805A-WELLINGTON-ST.-WEST.**

Drawing Title: **SITE-PLAN**


Project No.: **805A-WELLINGTON-ST.-WEST.**

Drawing Legend

- Siamese Connection
- Main Gas Shutoff Valve
- Municipal Fire Hydrant
- Designated Assembly Area
- Emergency Exit

2355 Derry Road East, Unit 6
 Mississauga, ON, L5S 1V6
 905-230-6388
VITAL SAFETY SERVICES

VSS

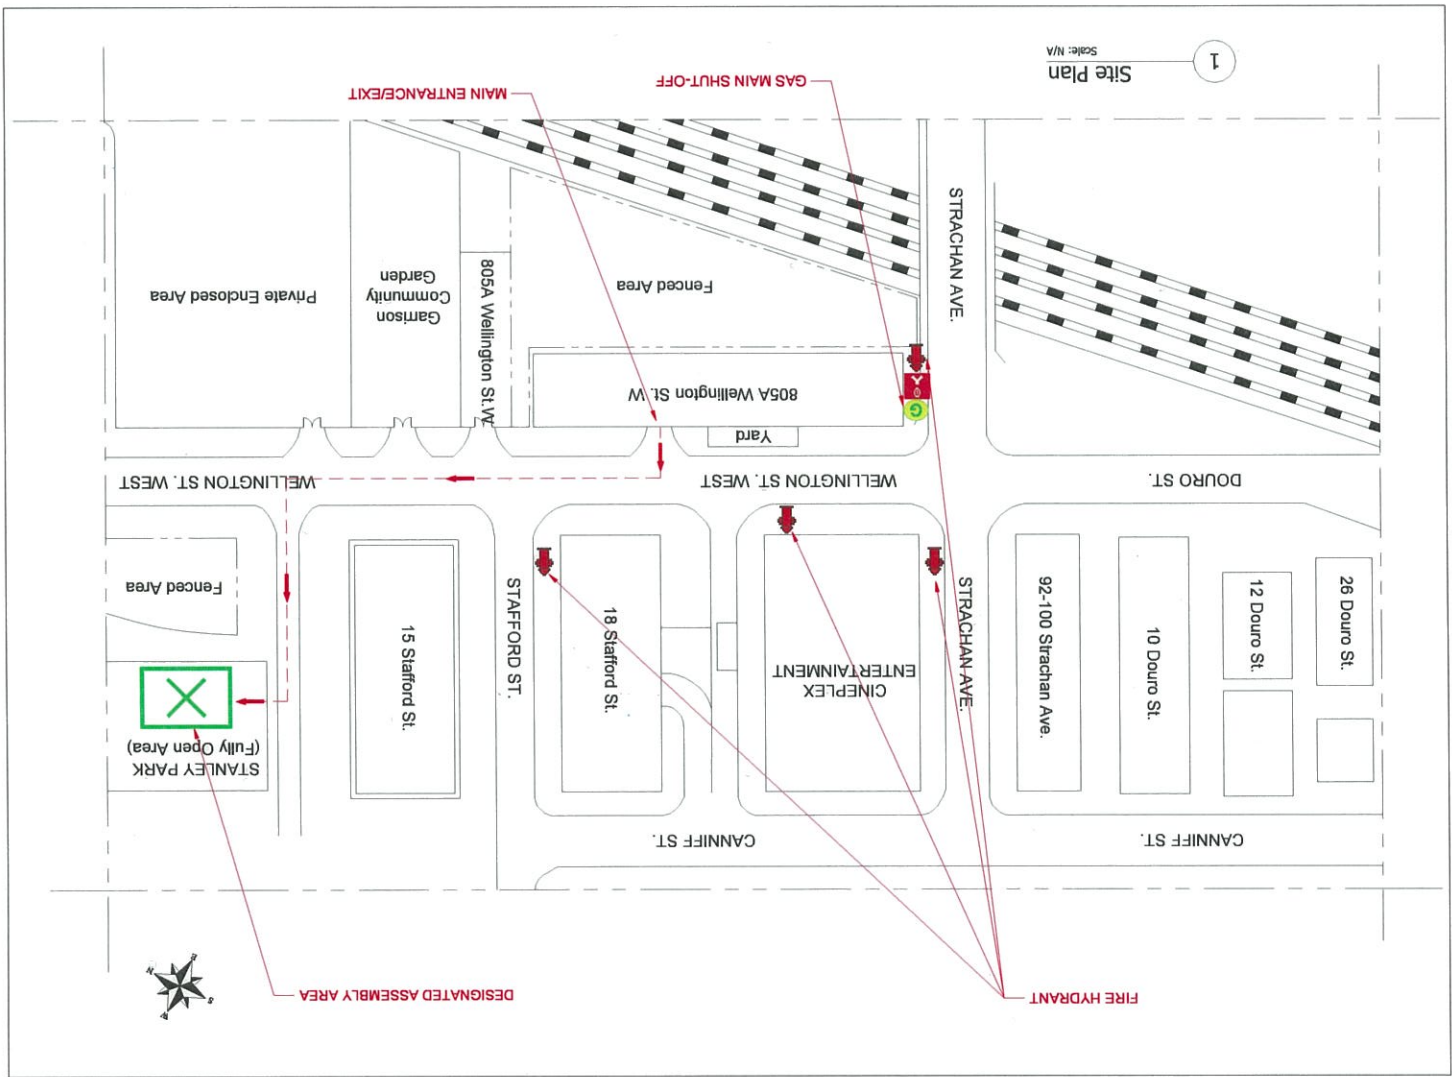

1
 Site Plan
 Scale: N/A